


- SD Smoke Detector
- CO Carbon Monoxide Detector
- H Rate Of Rise Heat Detector

All of the above are to be mains wired, interconnected

chimney breasts removed and steel supports installed to structural engineers details

En-suites to have extract ventilation - 15L/sec
 Kitchen to have extract ventilation - 30L/sec adjacent to the hob or 60L/sec elsewhere

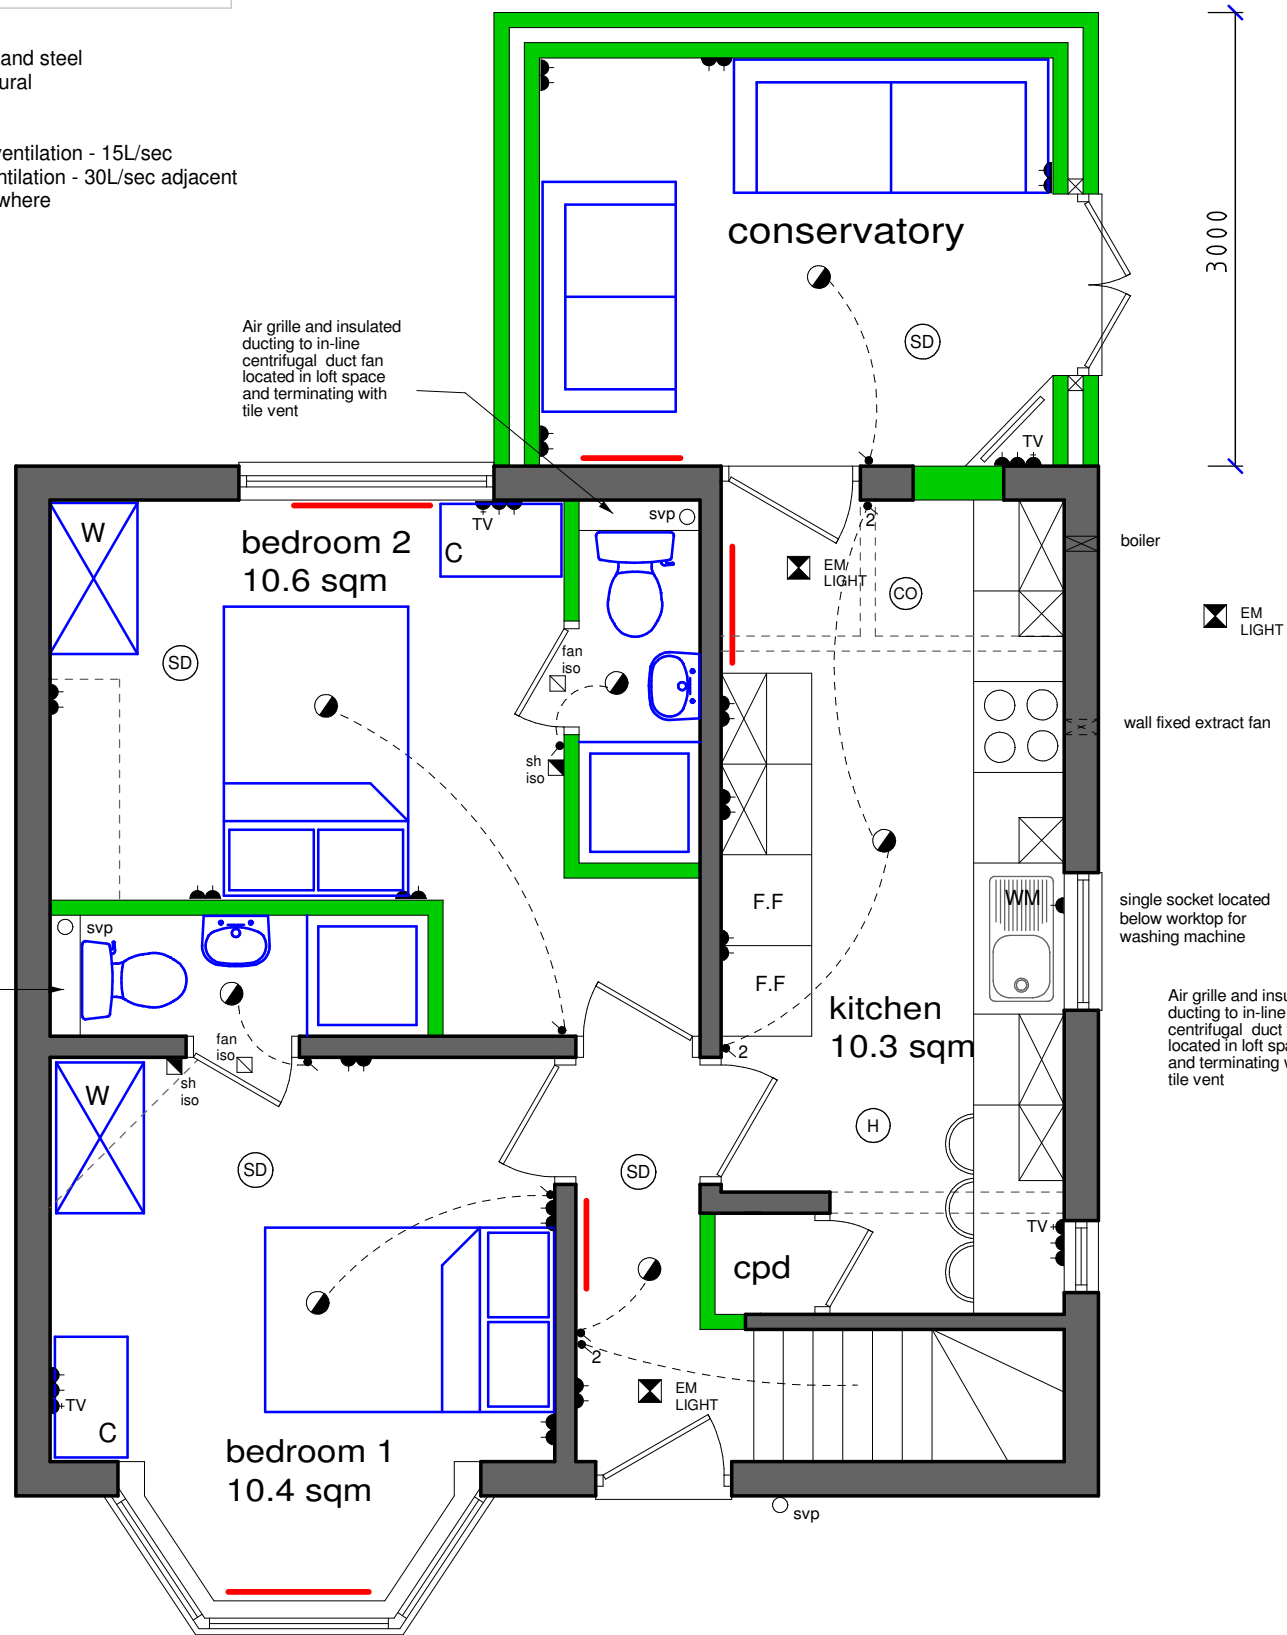

Ground Floor Plan

FOOT FORWARD PROPERTY INVESTMENTS


**27 DONCASTER ROAD
 WOODLANDS
 DONCASTER
 DN6 7QP**

PROPOSED PLANS

scale	date	drawn	checked
1:50 @ A3	SEP 19	PB	
drawing no	revision		
FF - 136- 2	B		

C3 Architecture Planning & Design

Tel 07914 939157
 web www.c3planninganddesign.co.uk
 email info@c3planninganddesign.co.uk

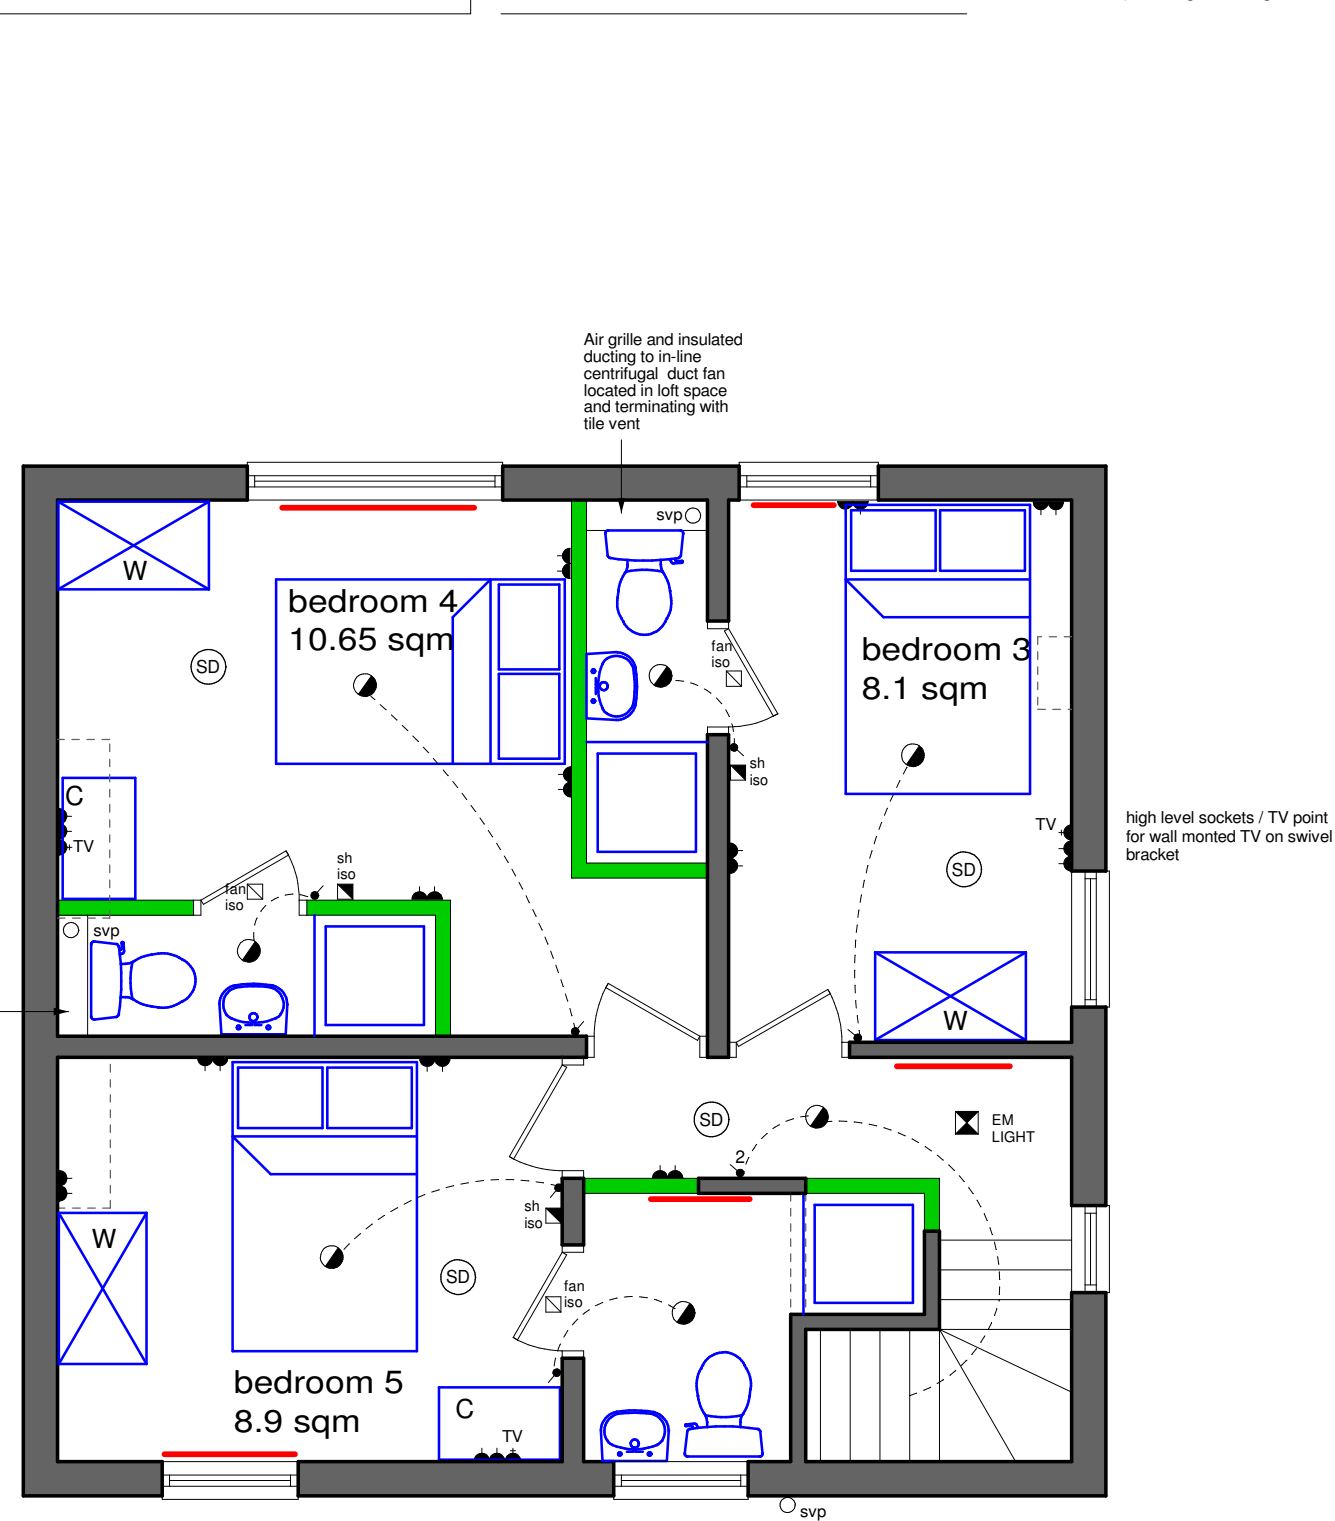

First Floor Plan

extg
mh